

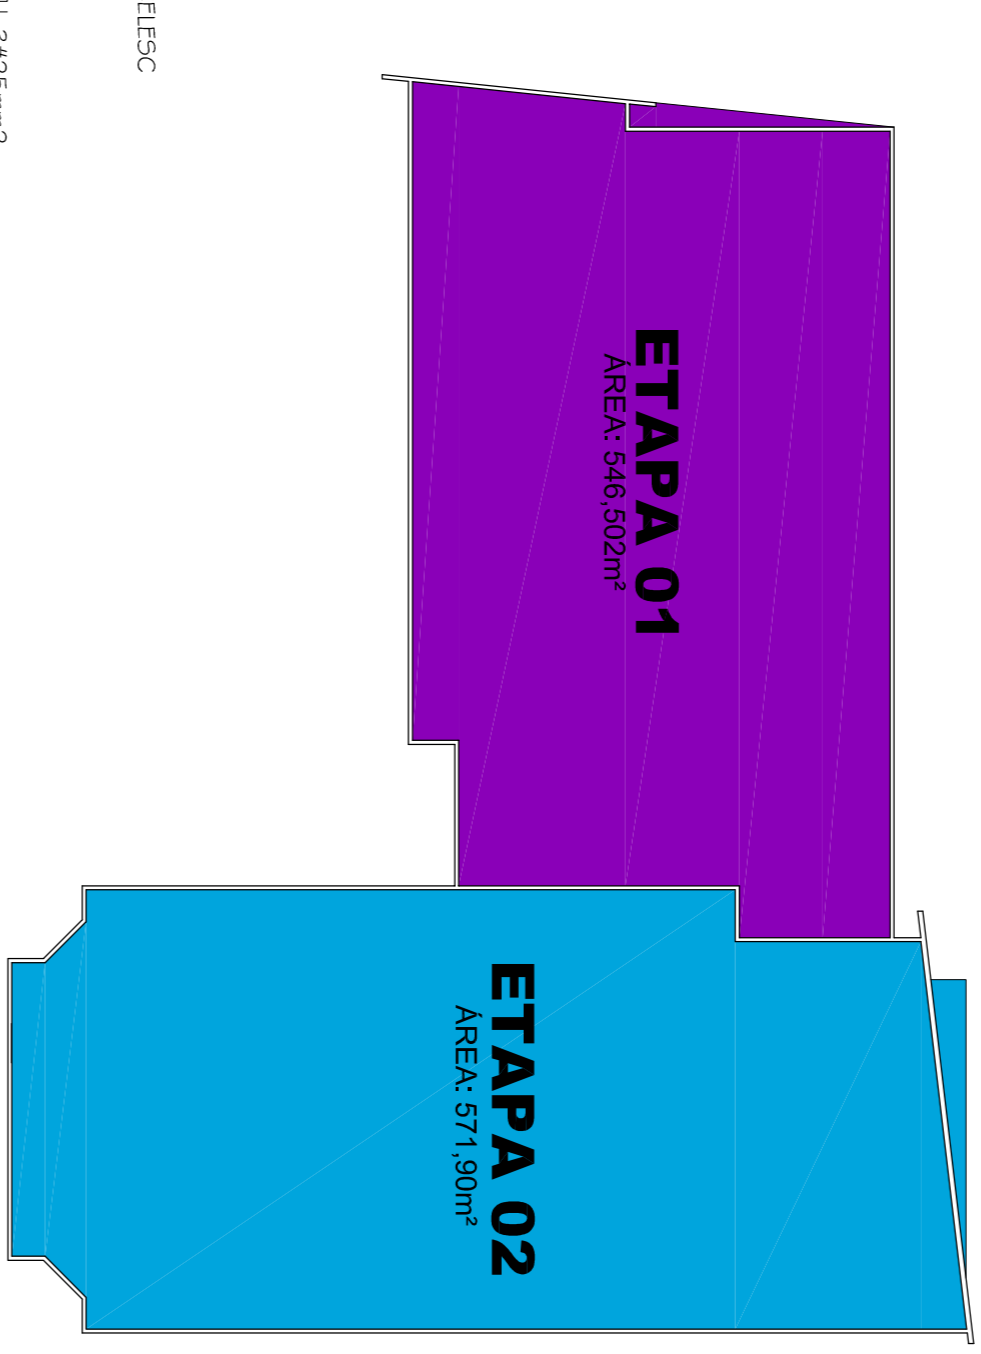


QUADRO GERAL DE CARGAS											
CIRCUITO	LAMPADAS W				TOMADAS W				CARGA	COMPTOR	DESAFIO/OK
	100	400	100	300	600	1000	2000	6000			
CIRCUITO 1				1.4	0.2				1.700	2.5	15
CIRCUITO 2			1.4						1.400	2.5	15
CIRCUITO 3								0.1	6.000	4.0	20
CIRCUITO 4									6.000	4.0	20
CIRCUITO 5								0.1	1.040	2.5	15
CIRCUITO 6									1.040	2.5	15
CIRCUITO 7									1.380	2.5	10
CIRCUITO 8									1.380	2.5	10
CIRCUITO 9			0.5						7.40	2.5	10
CIRCUITO 10								0.1	2.000	4.0	20
CIRCUITO 11									2.000	4.0	20
CIRCUITO 12									2.000	4.0	20
CIRCUITO 13									2.000	4.0	20
CIRCUITO 14									2.000	4.0	20
15. RESERVA											
16. RESERVA											
17. RESERVA											
TOTAL GERAL	48	08	00	25	02	00	00	06	02	31.740 W	362,0mm²

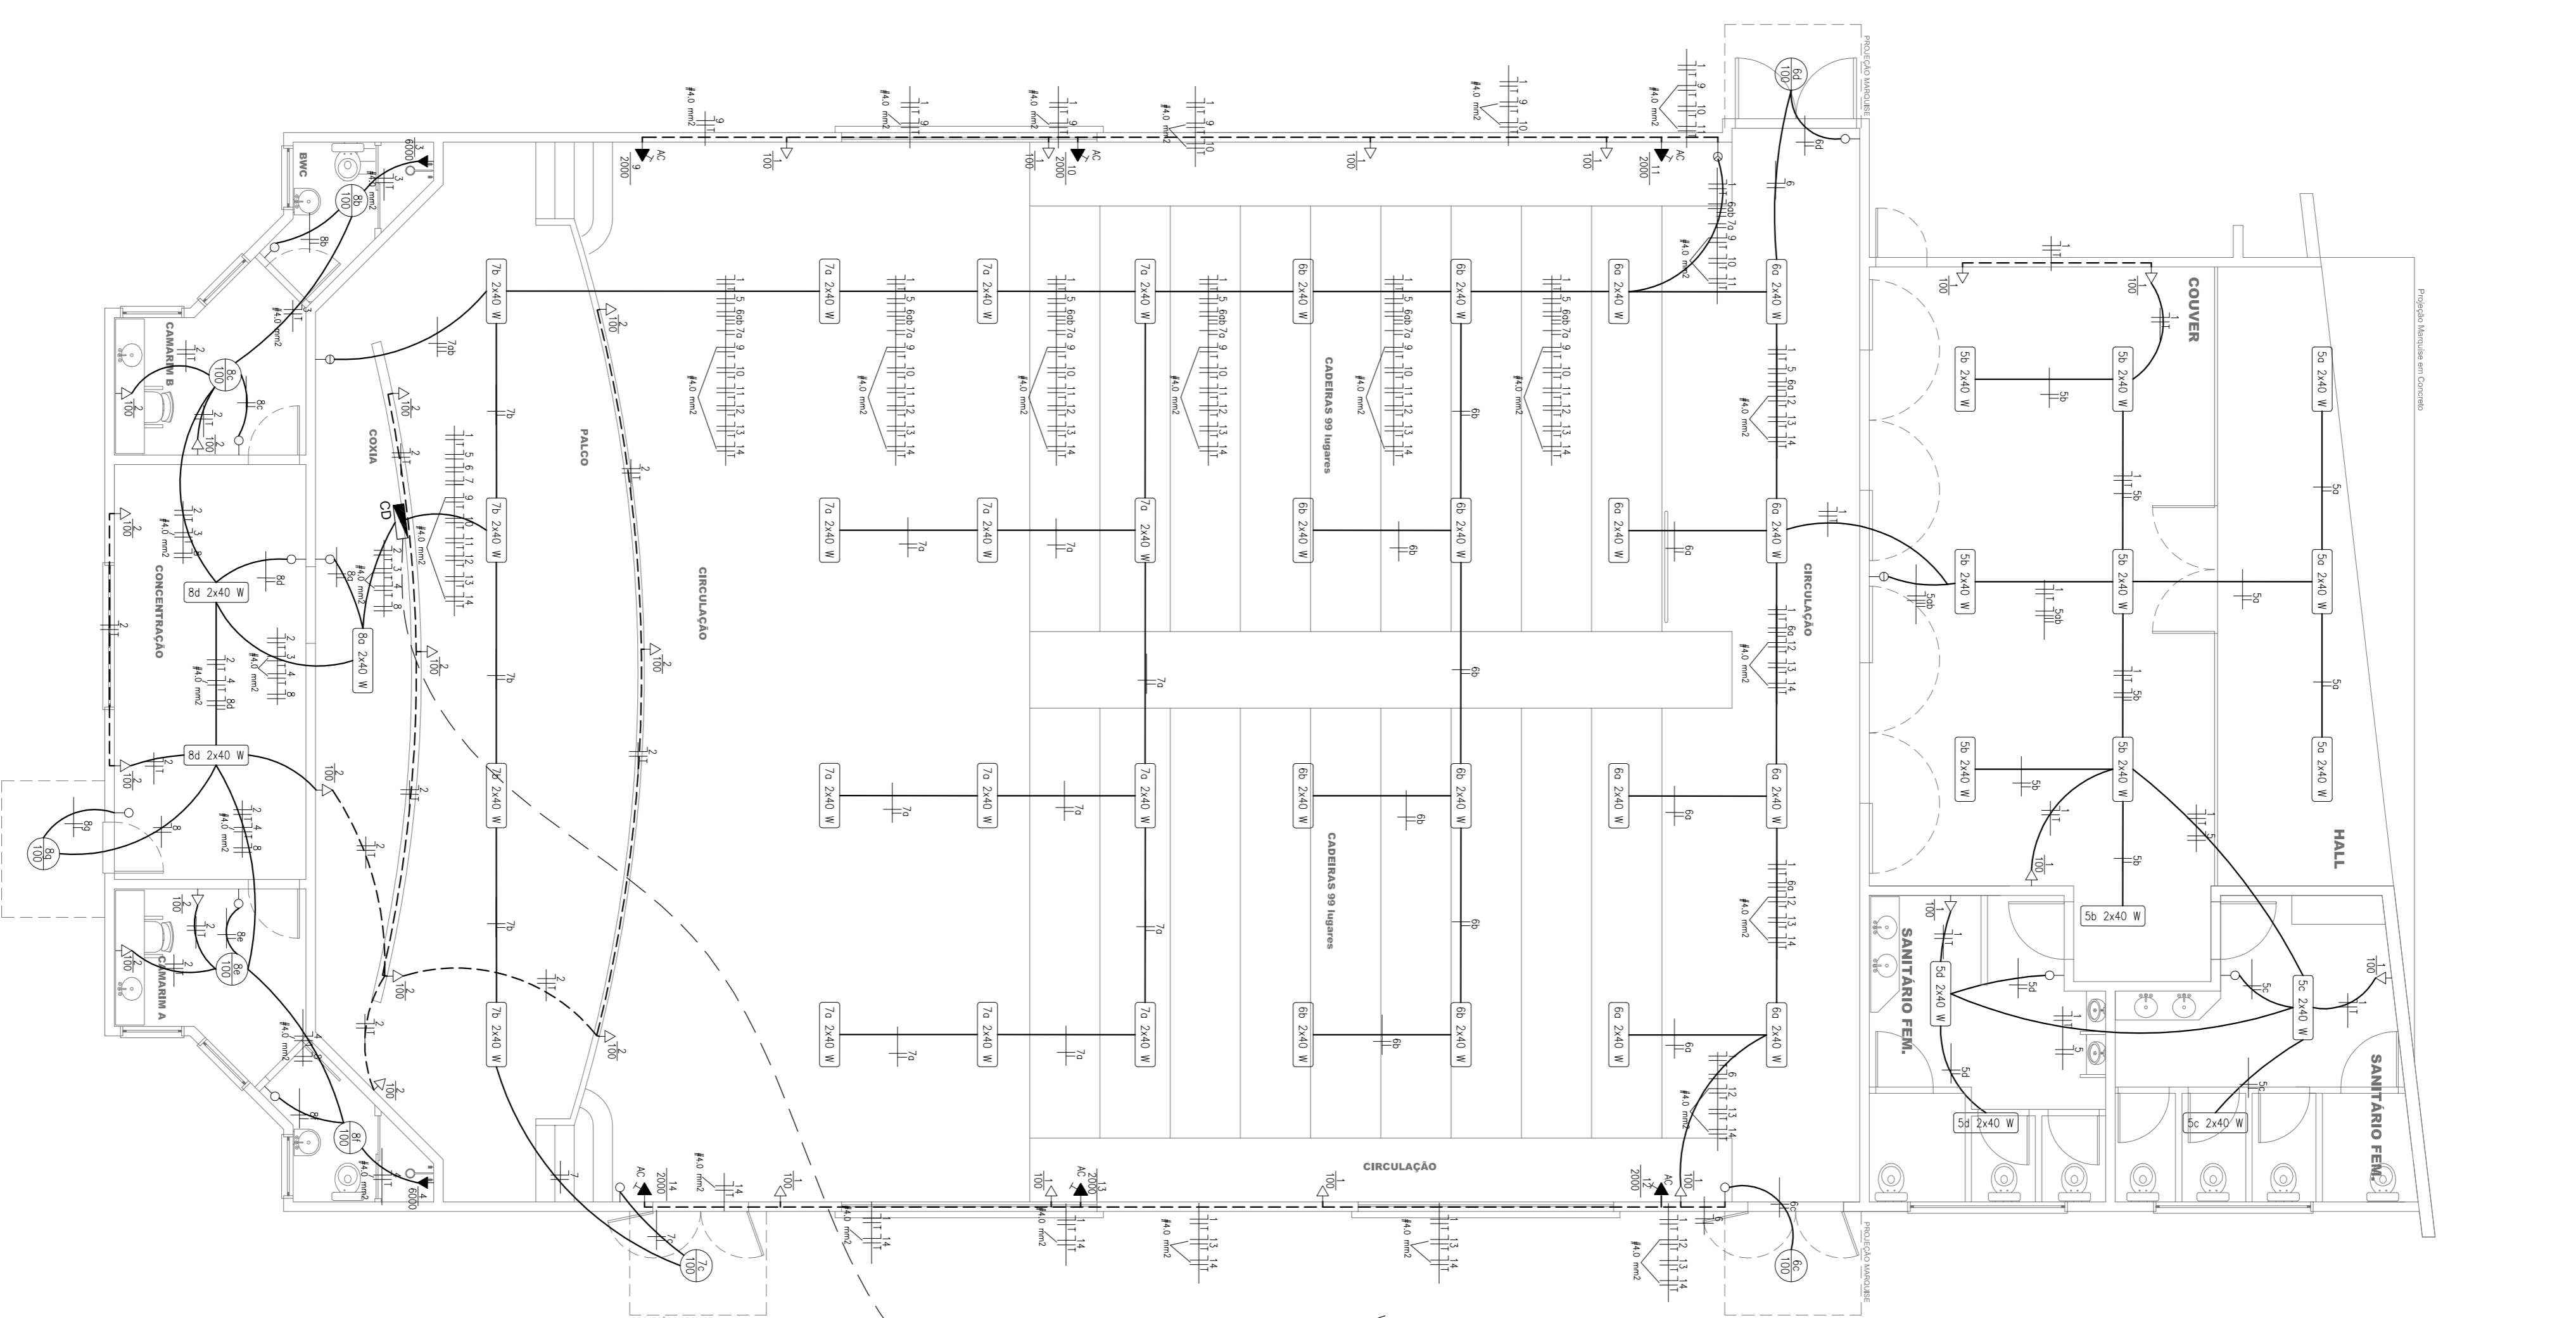

ARQUITETONICO

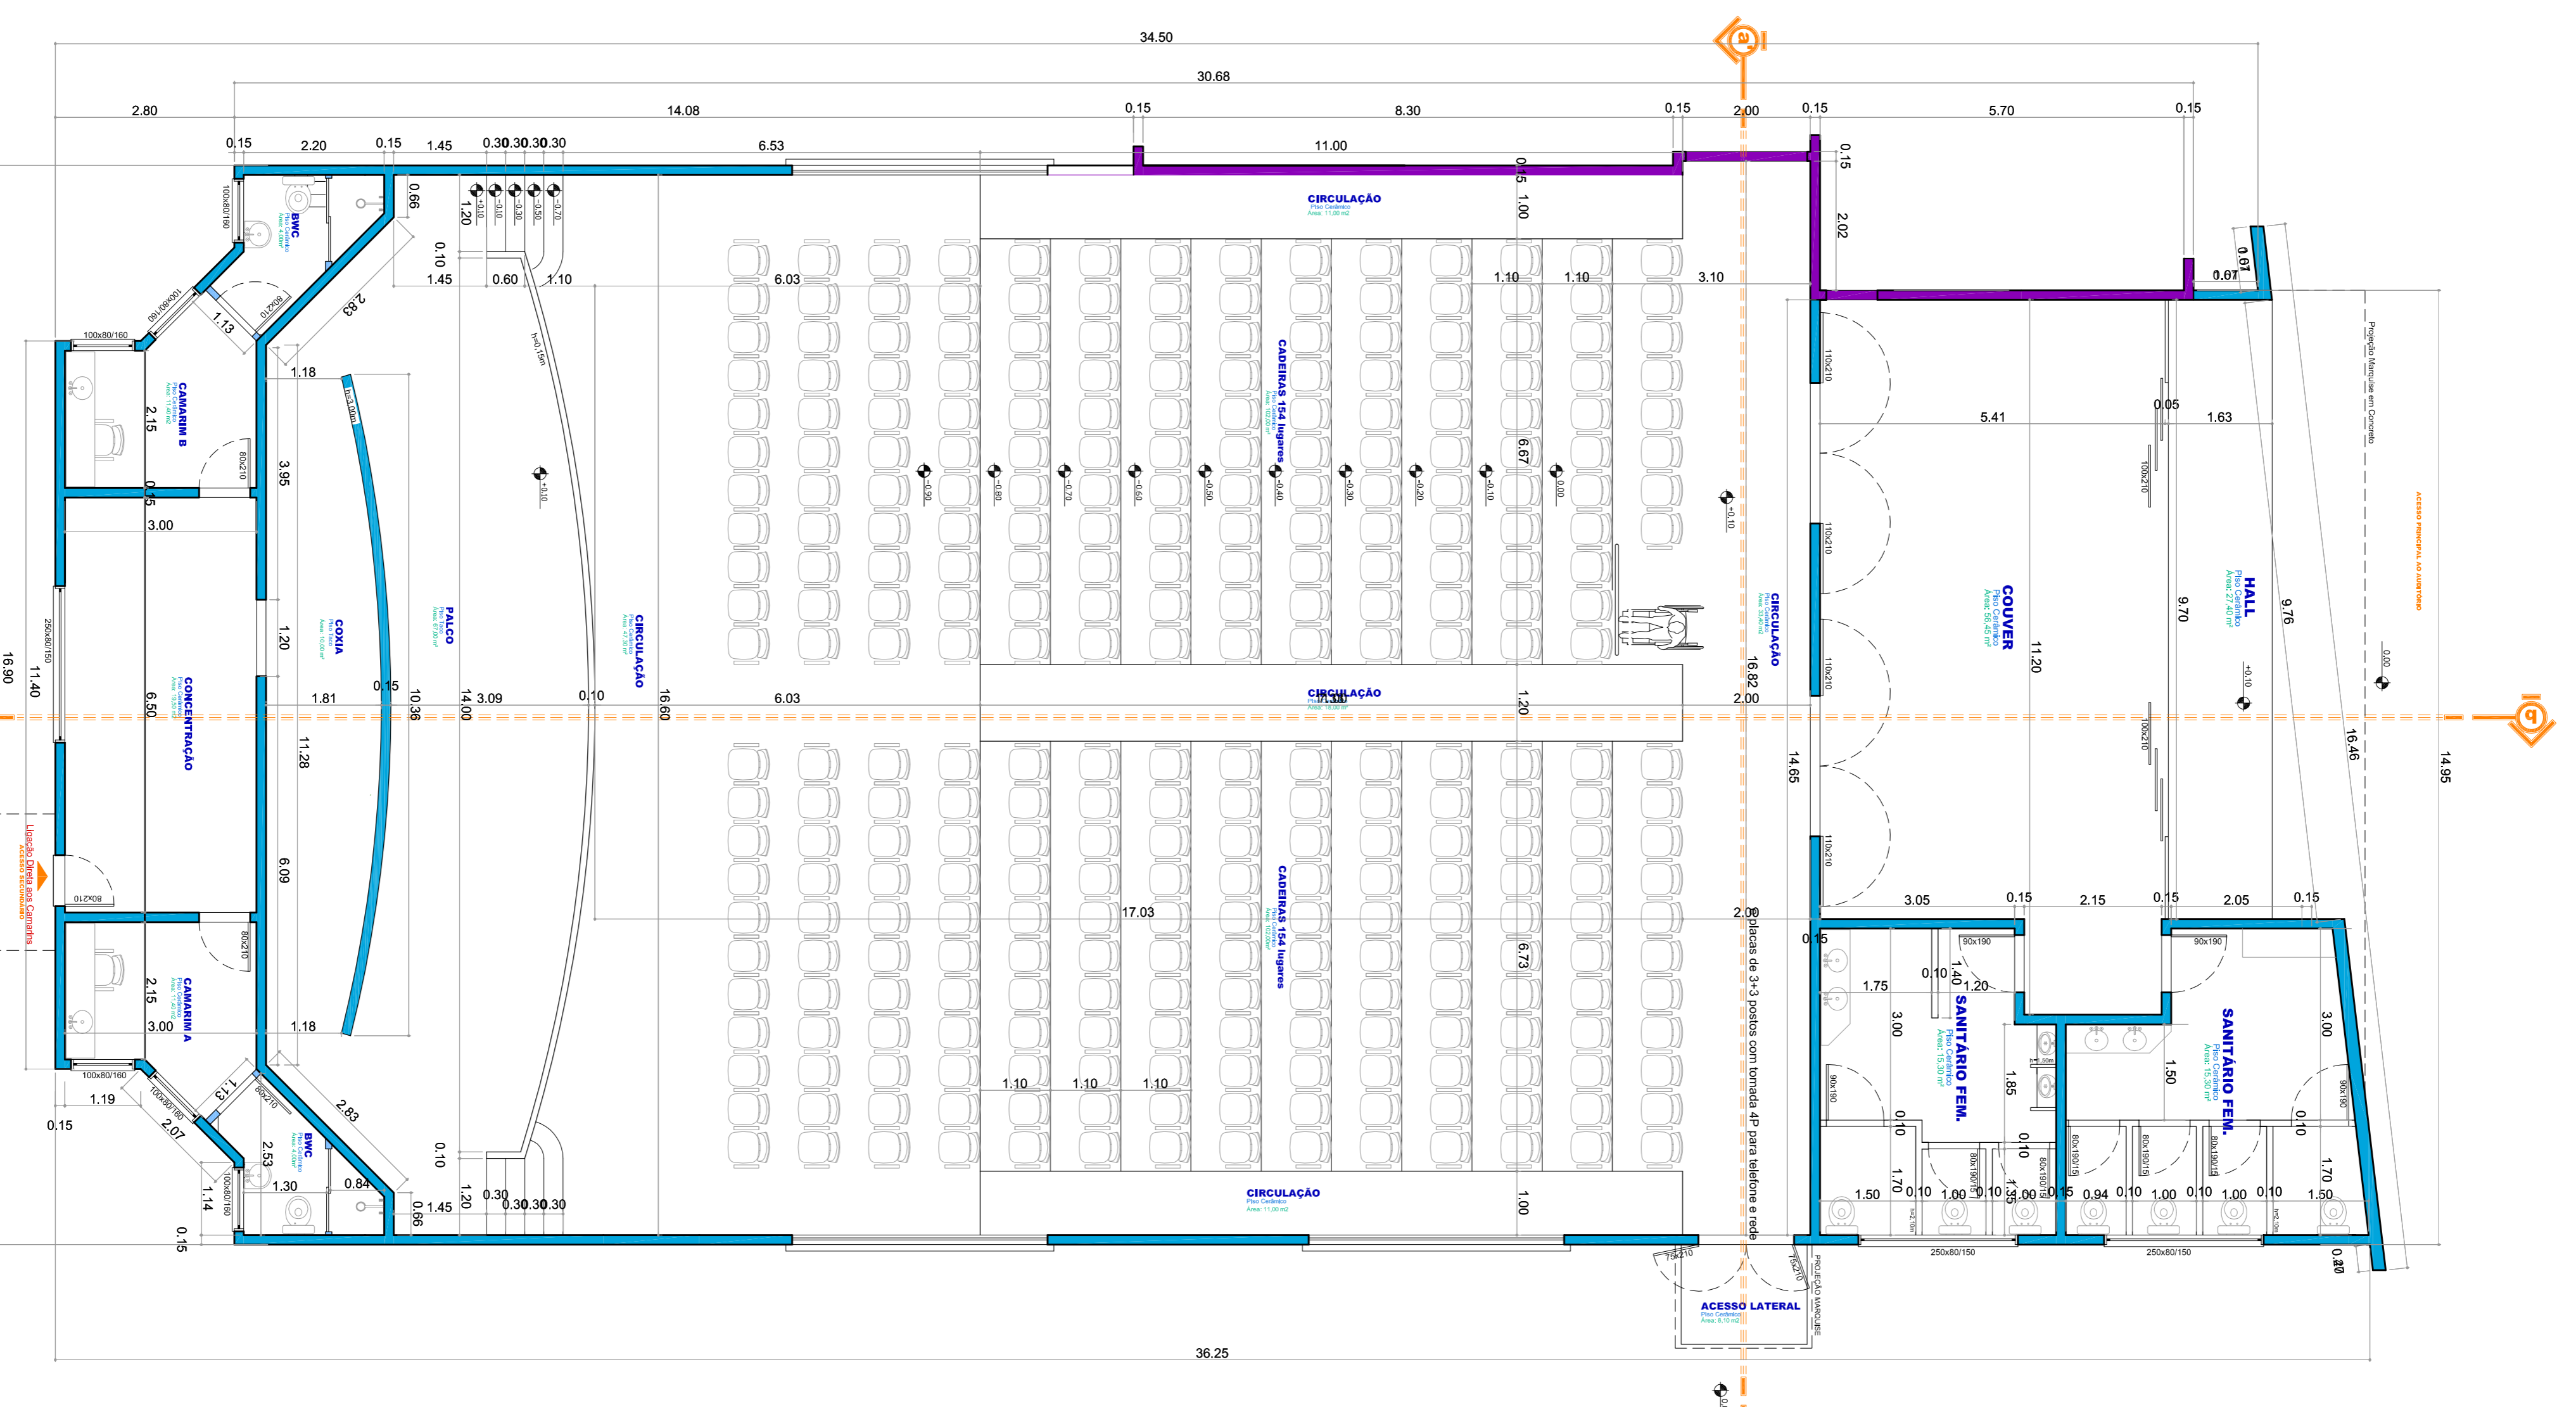

PLANTA BAIXA

ESCALA 1/75

ELÉTRICO

ESCALA 1/75



PREFEITURA MUNICIPAL DE CORONEL FREITAS

CENTRO DE EVENTOS - ETAPA 02

Rua Iguajú

Planta Baixa Elétrico

PROJETO: 01

Arquiteto e desenhistas: Michelle Raquel Demo

INDICADA

agosto/2013

4.400

1.113,83 m²

01

CentroWit.dwg